



15/02/22

DERBYN ADRAN CYLLUNIO

MINOR RE-ALIGNMENT OF KERB
AND PEDESTRIAN FOOTWAY TO
ALLOW VEHICLE ENTRY

EXISTING
SUBSTATION

ORME VIEW LODGES
1 RHOS ISAF
LLANDYGAU
BANGOR LL67 4BG

A5 TO BANGOR



PROPOSED SITE BLOCK PLAN SCALE 1:500

PLANNING ISSUE

REVISIONS:

REV	DESCRIPTION	DATE	CHK	APP
A	PRE APP PLANNING ISSUE	16-10-20	IR	IR
B	PRE APP PLANNING ISSUE	19-02-21	IR	IR
C	PRE APP PLANNING ISSUE	13-07-21	MS	MS
D	PRE APP PLANNING ISSUE	21-10-21	MS	MS
E	PLANNING ISSUE	25-10-21	MS	MS
F	PLANNING ISSUE	11-02-22	MS	MS

NOTES

1. ALL DIMENSIONS SHOWN ARE IN MILLIMETRES
UNLESS OTHERWISE STATED.

KEY

	PROPOSED CNG FUELS LTD STATION REDLINE BOUNDARY.
	CNG FUELS SECURITY PALISADE FENCE 2.4m HIGH
	CNG FUELS SECURITY ACCOUSTIC FENCE 3.5m HIGH
	CNG FUELS LTD. SITE BOUNDARY FENCE V MESH IN BLACK 2.4m HIGH
	CNG FUELS LTD. SITE BOUNDARY FENCE ACCOUSTIC CLOSE BOARDED TIMBER 2.8m HIGH
	SURFACE CHANNEL FOR BELOW GROUND PIPE ROUTING.
	RETAINING WALL STRUCTURE.

CLIENT:
-

PROJECT:
BANGOR CNG STATION
CEGIN

TITLE:
PROPOSED CNG STATION
PROPOSED SITE BLOCK PLAN

SCALE: 1:500	@ A1	DRAWN: KJB
CHECKED: IR	CAD: DATE: 15/10/2020	
APPROVED: IR	SHEET: 1 OF 1	

PROJECT No: 020

DRAWING No: 020-01-CNG-103

REVISION: F



16 BERKELEY STREET
LONDON
W1J 8DZ

TEL: 02039 073936
WEB: www.cngfuels.com

15/02/22
DERBYN ADRAN CYLLUNIO

PLANNING ISSUE

REV	DESCRIPTION	DATE	CHK	APP
A	PRE APP PLANNING ISSUE	16-10-20	IR	IR
B	PRE APP PLANNING ISSUE	19-02-21	IR	IR
C	PRE APP PLANNING ISSUE	13-07-21	MS	MS
D	PRE APP PLANNING ISSUE	17-09-21	MS	MS
E	PRE APP PLANNING ISSUE	21-10-21	MS	MS
F	PLANNING ISSUE	25-10-21	MS	MS
G	PLANNING ISSUE	11-02-22	MS	MS

NOTES

- ALL DIMENSIONS SHOWN ARE IN MILLIMETRES UNLESS OTHERWISE STATED.
- TO BE READ IN CONJUNCTION WITH PROPOSED SITE ELEVATION VIEWS. DRG. No. 020-01-CNG-105

KEY

	CNG FUELS SECURITY PALISADE FENCE 2.4m HIGH
	CNG FUELS SECURITY ACOUSTIC FENCE 3.5m HIGH
	CNG FUELS LTD. SITE BOUNDARY FENCE V MESH IN BLACK 2.4m HIGH
	CNG FUELS LTD. SITE BOUNDARY FENCE ACOUSTIC CLOSE BOARDED TIMBER 2.8m HIGH
	SURFACE CHANNEL FOR BELOW GROUND PIPE ROUTING.
	RETAINING WALL STRUCTURE.

CLIENT:
-

PROJECT:
BANGOR CNG STATION
CEGIN

TITLE:
PROPOSED CNG STATION
PROPOSED SITE PLAN


SCALE: 1:250 @ A1 DRAWN: KJB
CHECKED: IR CAD: DATE: 15/10/2020
APPROVED: IR SHEET: 1 OF 1

PROJECT No: 020

DRAWING No: 020-01-CNG-105

REVISION: G

16 BERKELEY STREET
LONDON
W1J 8DZ
TEL: 02039 073936
WEB: www.cngfuels.com

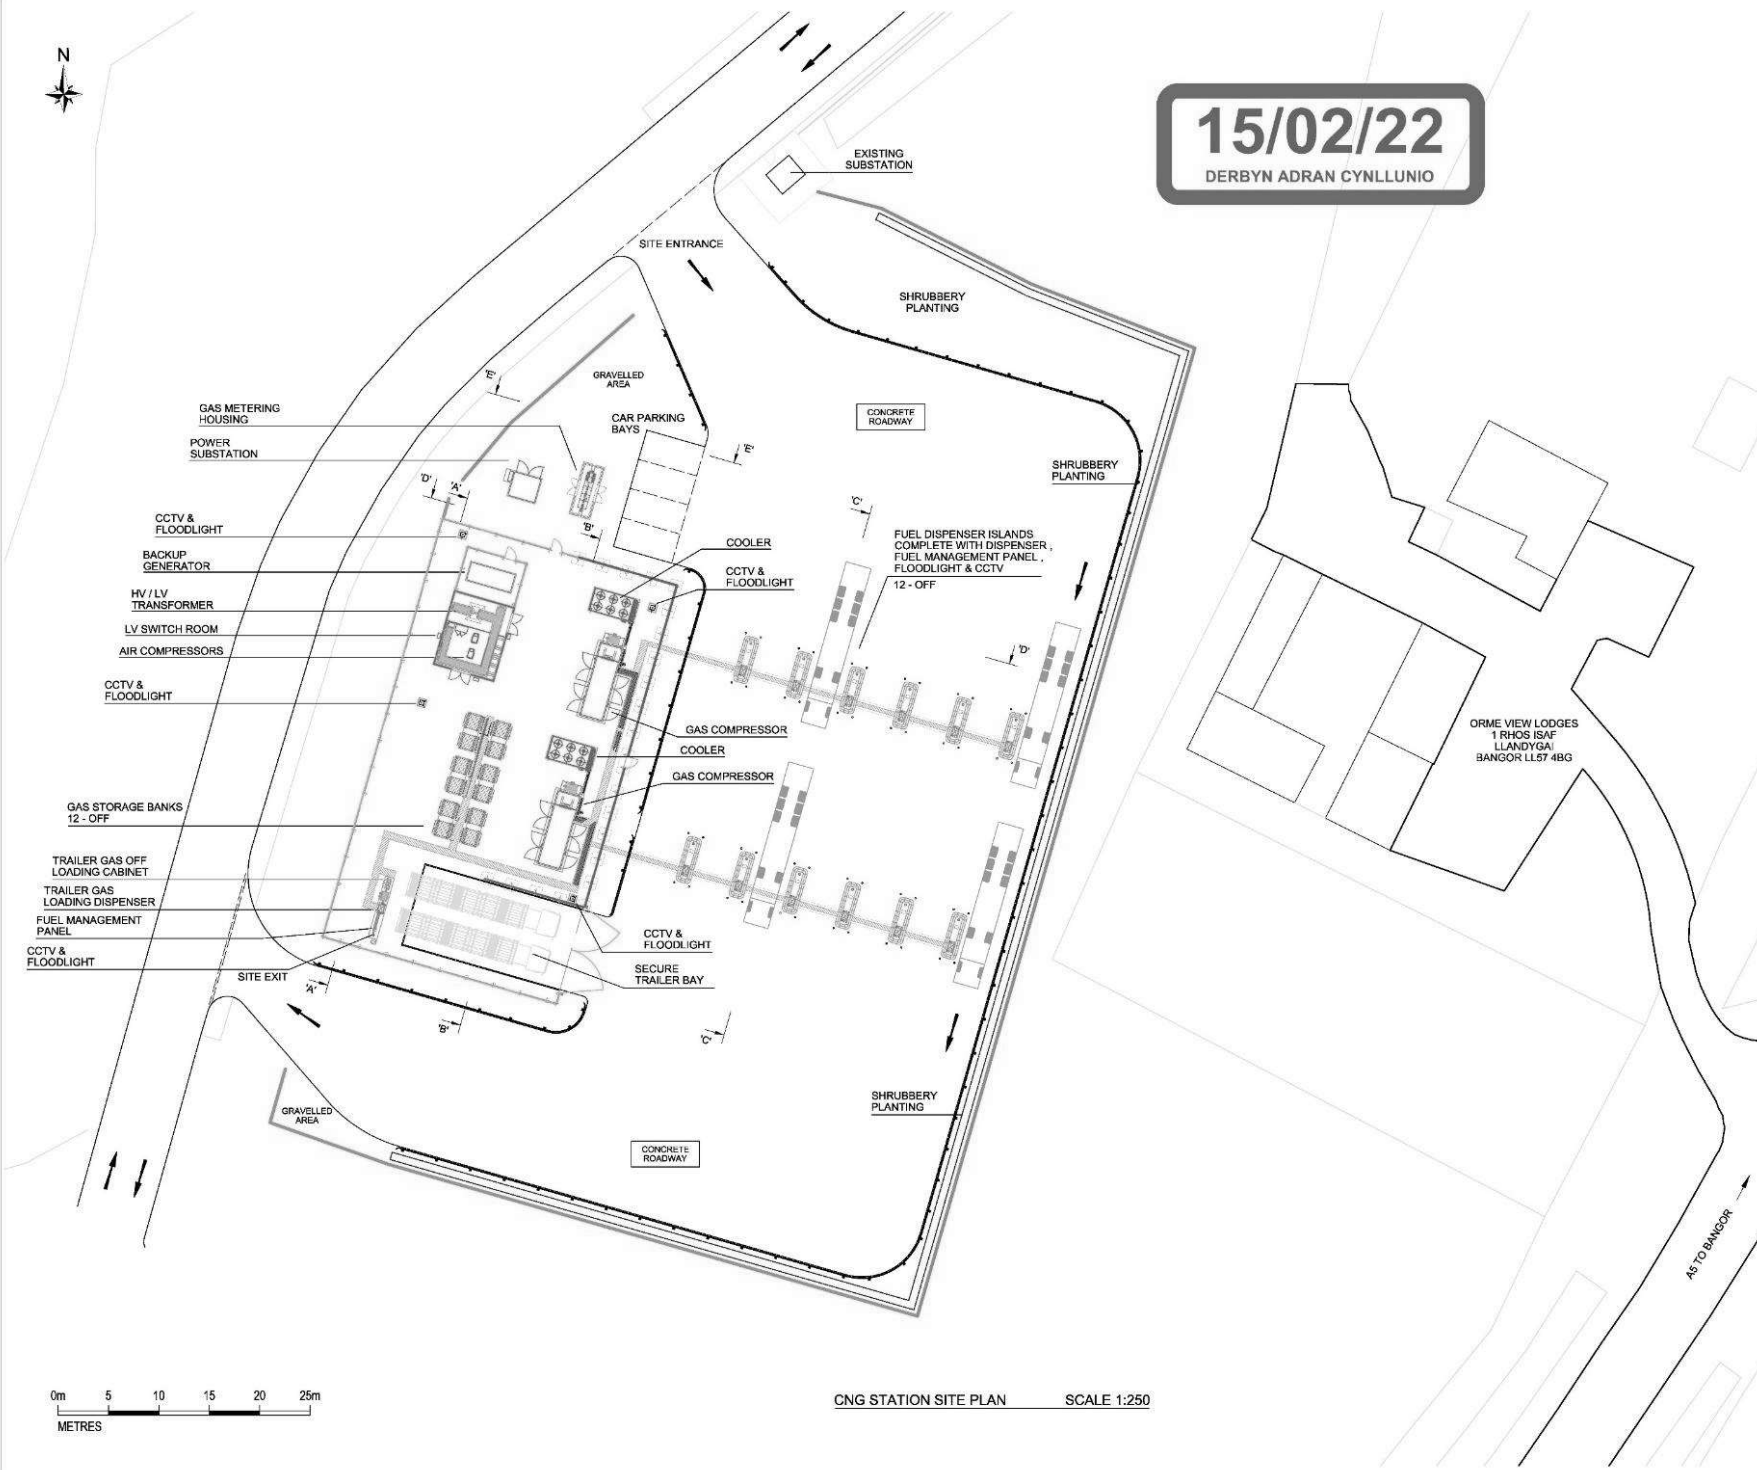

CNG STATION SITE PLAN SCALE 1:250



SITE ENTRANCE

15/02/22
DERBYN ADRAN CYLLUNIO







PLANNING ISSUE

REV	DESCRIPTION	DATE	CHK	APP
A	PRE APP PLANNING ISSUE	13-07-21	MS	MS
B	PRE APP PLANNING ISSUE	21-10-21	MS	MS
C	PLANNING ISSUE	25-10-21	MS	MS
D	PLANNING ISSUE	11-02-22	MS	MS

NOTES

1. ALL DIMENSIONS SHOWN ARE IN MILLIMETRES UNLESS OTHERWISE STATED.

KEY

-  CNG FUELS SECURITY PALISADE FENCE 2.4m HIGH
-  CNG FUELS SECURITY ACQUSTIC FENCE 3.5m HIGH
-  CNG FUELS LTD. SITE BOUNDARY FENCE V MESH IN BLACK 2.4m HIGH
-  CNG FUELS LTD. SITE BOUNDARY FENCE ACQUSTIC CLOSE BOARDED TIMBER 2.8m HIGH
-  SURFACE CHANNEL FOR BELOW GROUND PIPE ROUTING.
-  RETAINING WALL STRUCTURE.

CLIENT:

PROJECT:

BANGOR CNG STATION
CEGIN

TITLE:

PROPOSED CNG STATION
PROPOSED SITE LIGHTING PLAN

SCALE: 1:200 @ A1 DRAWN: KJB
CHECKED: MS CAD: DATE: 13/07/2021
APPROVED: MS SHEET: 1 OF 1

PROJECT No: 020

DRAWING No: 020-01-CNG-107

REVISION: D

 16 BERKELEY STREET
LONDON
W1J 8DZ
TEL: 02039 073936
WEB: www.cngfuels.com

SITE EXIT


ORME VIEW LODGES
1 RHOS ISAF
LLANDYSAI
BANGOR LL67 4BG

LIGHT LIST	
ITEM	DESCRIPTION
2	LOW LEVEL LIGHTING 1M HIGH POST MOUNTED ON COOLER BASE TO ILLUMINATE WALKWAY ALONG COMPRESSOR SIDES.
3	EMERGENCY EXIT LIGHT / SIGN
4	BULKHEAD LIGHT MOUNTED ON OUTSIDE OF SWITCH ROOM

LUMINAIRE MOUNTING

ITEM 1 - ALL 1982 MICRO RODIO FLOODLIGHTS MOUNTED ON 4M FLANGE PLATE MOUNTED COLUMNS WITH TWIN FLOODLIGHT BRACKETS. THESE COLUMNS ARE MOUNTED ON EQUIPMENT CONCRETE PLINTH, ONE FLOODLIGHT TILTED UP BY 10 DEGREES AND ONE FLOODLIGHT TILTED UP BY 30 DEGREES. BOTH AIMED IN DIRECTION OF FUEL STATION TRAFFIC (AWAY FROM DRIVERS)


ASYMMETRIC FLOODLIGHT MOUNTING

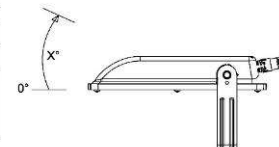





LUMINAIRE LIST	
ITEM	DESCRIPTION
1	DISANO 1982 MICRO RODIO 28W LED IP66 ASYMMETRIC FLOODLIGHT IN GRAPHITE

0m 5 10 15 20 25m
METRES

CNG STATION SITE PLAN SCALE 1:200

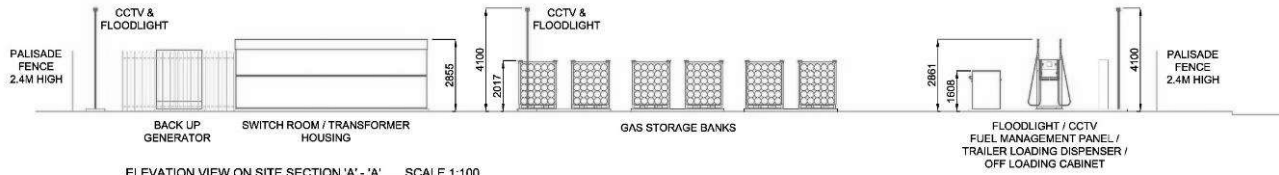

15/02/22
DERBYN ADRAN CYNLLUNIO

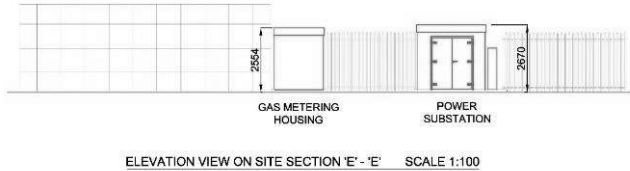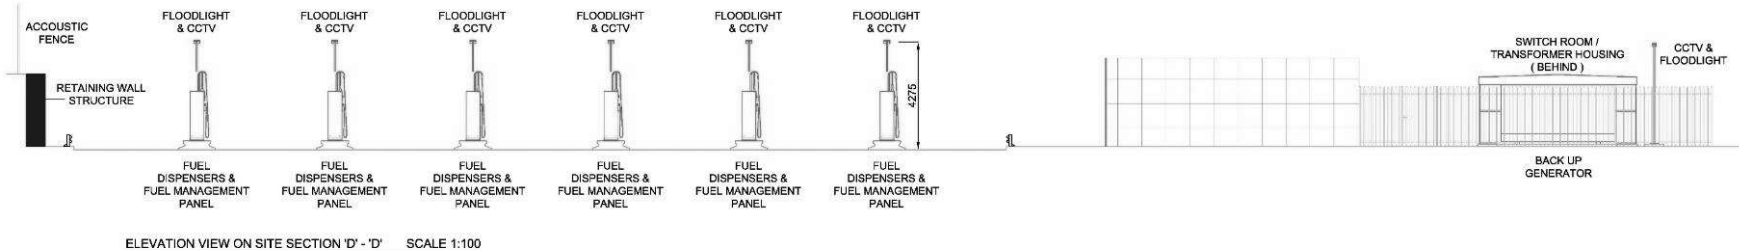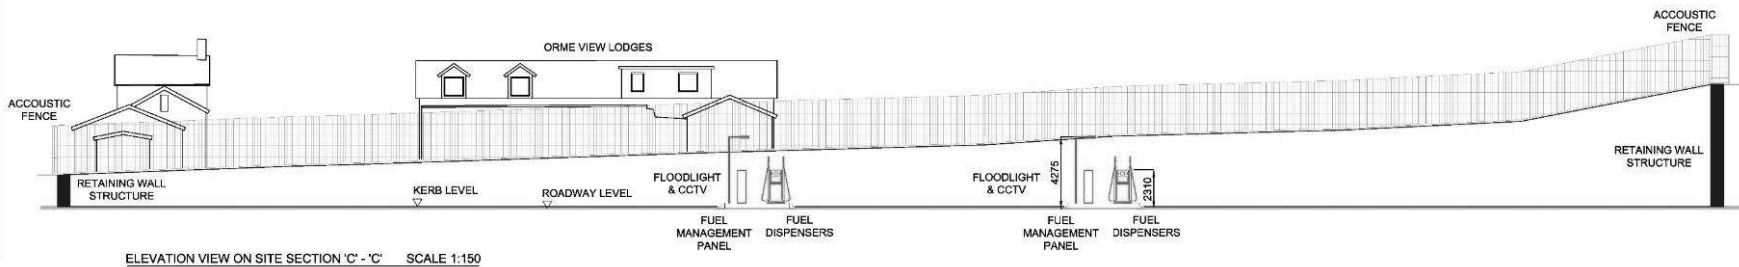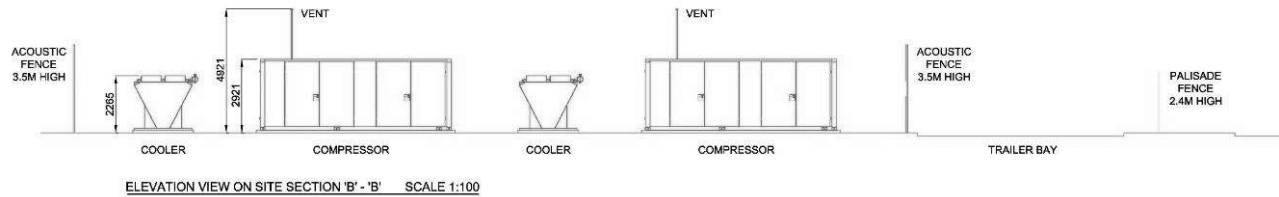

PLANNING ISSUE

REVISIONS:

REV	DESCRIPTION	DATE	CHK	APP
A	PRE APP PLANNING ISSUE	16-10-20	IR	IR
B	PRE APP PLANNING ISSUE	19-02-21	IR	IR
C	PRE APP PLANNING ISSUE	13-07-21	MS	MS
D	PRE APP PLANNING ISSUE	17-09-21	MS	MS
E	PLANNING ISSUE	25-10-21	MS	MS
F	PLANNING ISSUE	11-02-22	MS	MS

NOTES
 1. ALL DIMENSIONS SHOWN ARE IN MILLIMETRES UNLESS OTHERWISE STATED.
 2. TO BE READ IN CONJUNCTION WITH PROPOSED SITE PLAN. DRG. No. 020-01-CNG-105

KEY

	2.4M HIGH PALISADE FENCE
	GAS COMPOUND ACOUSTIC FENCE 3.5m HIGH
	CNG FUELS LTD. SITE BOUNDARY FENCE ACOUSTIC CLOSE BOARDED TIMBER 2.8m HIGH

CLIENT:
-

PROJECT:
BANGOR CNG STATION
CEGIN

TITLE:
PROPOSED CNG STATION
SITE ELEVATION VIEWS

SCALE: 1:100 @ A1 DRAWN: KJB
 CHECKED: IR CAD: DATE: 15/10/2020
 APPROVED: IR SHEET: 1 OF 1

PROJECT No: 020
 DRAWING No: 020-01-CNG-106

REVISION: F

16 BERKELEY STREET
LONDON
W1J 8DZ
TEL: 02039 073936
WEB: www.cngfuels.com













